

MARK	DATE	DESCRIPTION
△	09/09/09	RETAIL STORE UPFIT
△	04/23/08	RFI #24
4	09/07/07	AS2 * 006
CD	03/08/07	BID SET

PROJECT NO.: FWA 2214.01
SCO 020572301


DRAWN BY:

APPROVED BY:

THESE DRAWINGS AND THE PROJECT MANUAL ARE INSTRUMENTS OF SERVICE AND REMAIN THE PROPERTY OF THE FWA GROUP ARCHITECTS. UNAUTHORIZED DUPLICATION OR REUSE WITHOUT WRITTEN CONSENT IS PROHIBITED.

SHEET TITLE
LOWER LEVEL PLUMBING PLAN - AREA "A" PRESSURE PIPING
SHEET NUMBER

P203

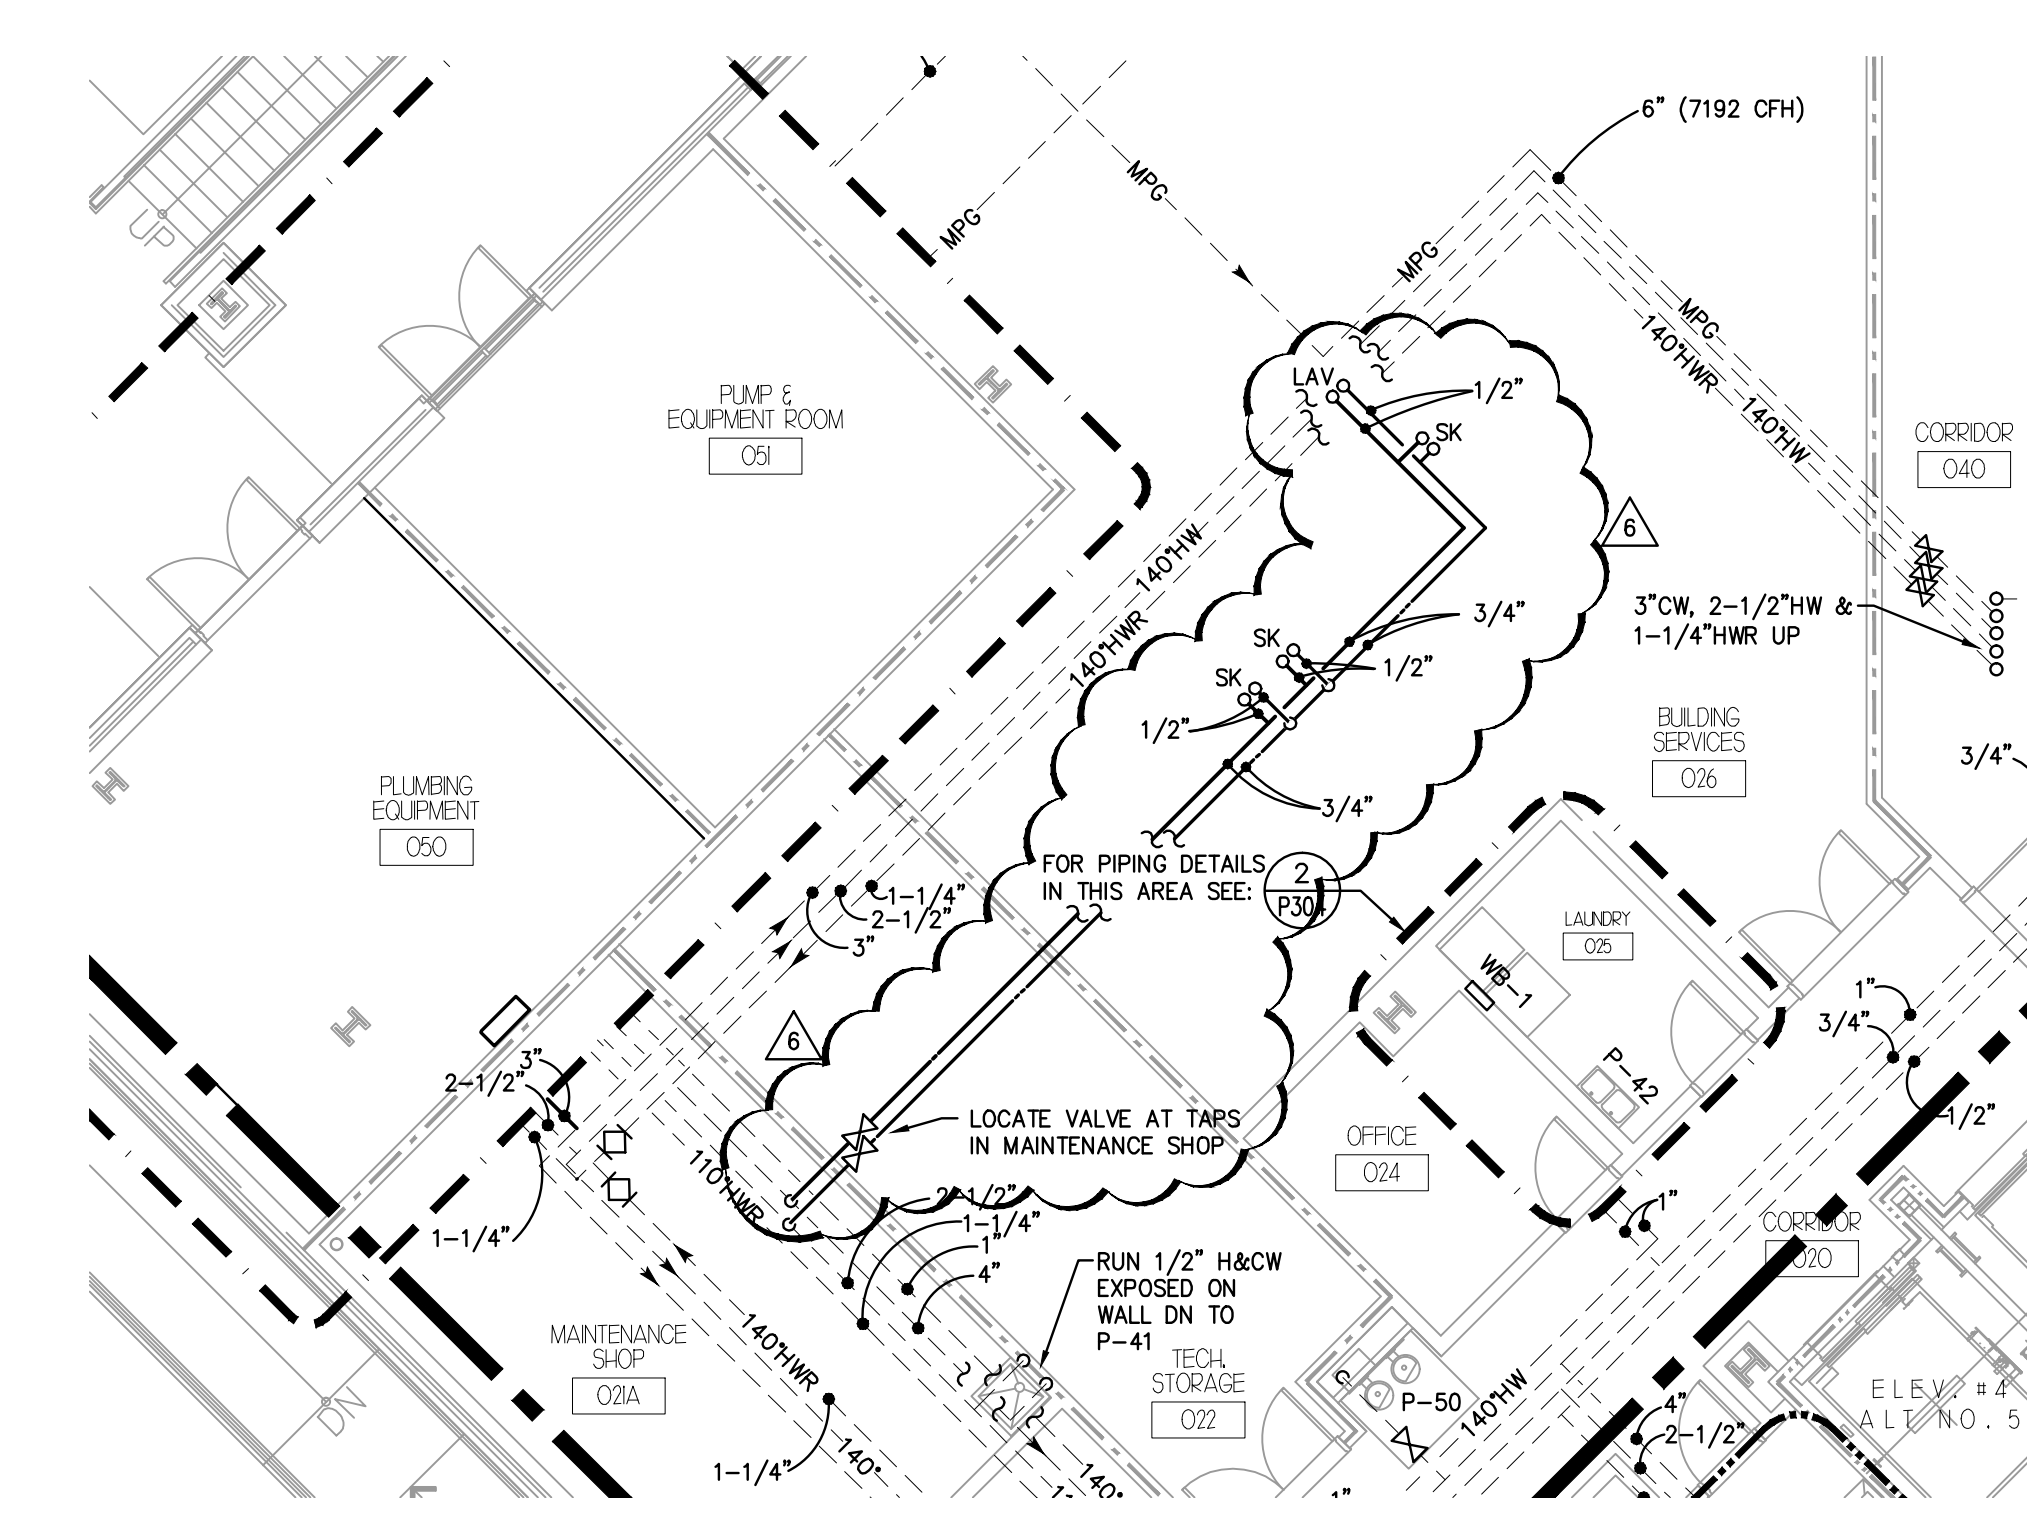


2 RETAIL #4 - PRESSURE PIPING
P203 SCALE: 1/8" = 1'-0"

GENERAL RETAIL UPFIT NOTES


- THE PARTIAL PLANS SHOWN ON THIS DRAWING IDENTIFY THE NEW WORK RELATED TO RETAIL UPFIT WORK. THE ENTIRE FLOOR PLAN SHOWS THE EXISTING WORK. THE EXISTING WORK IN PARTIAL PLAN IS IDENTIFIED DASHED AND NEW WORK IS IDENTIFIED BOLD.
- SPECIFICATIONS AND DRAWINGS FOR THE BASE PROJECT APPLY.

WALL FIRE RESISTANCE RATINGS LEGEND:

2 HOUR SEPARATION
1 HOUR SEPARATION

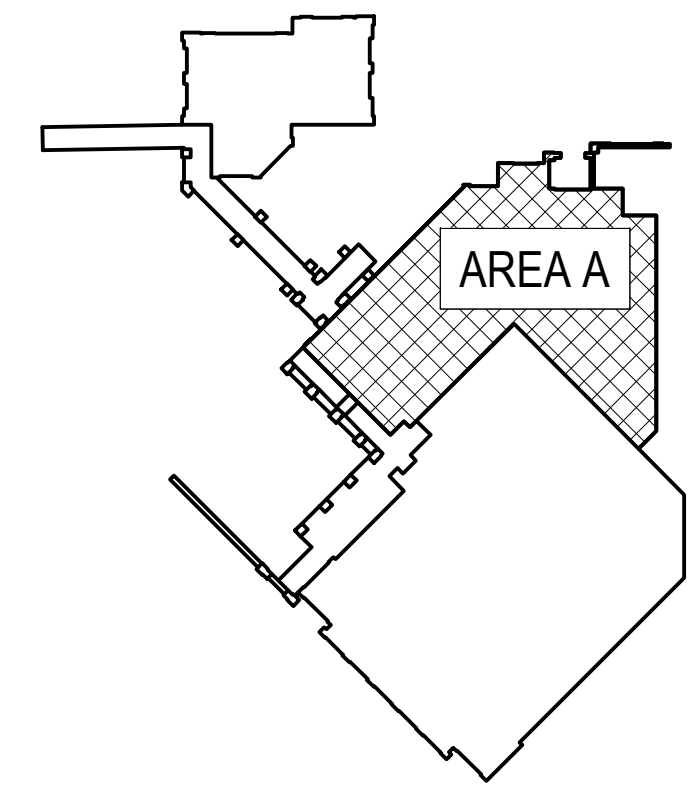

LOWER LEVEL KEYPLAN

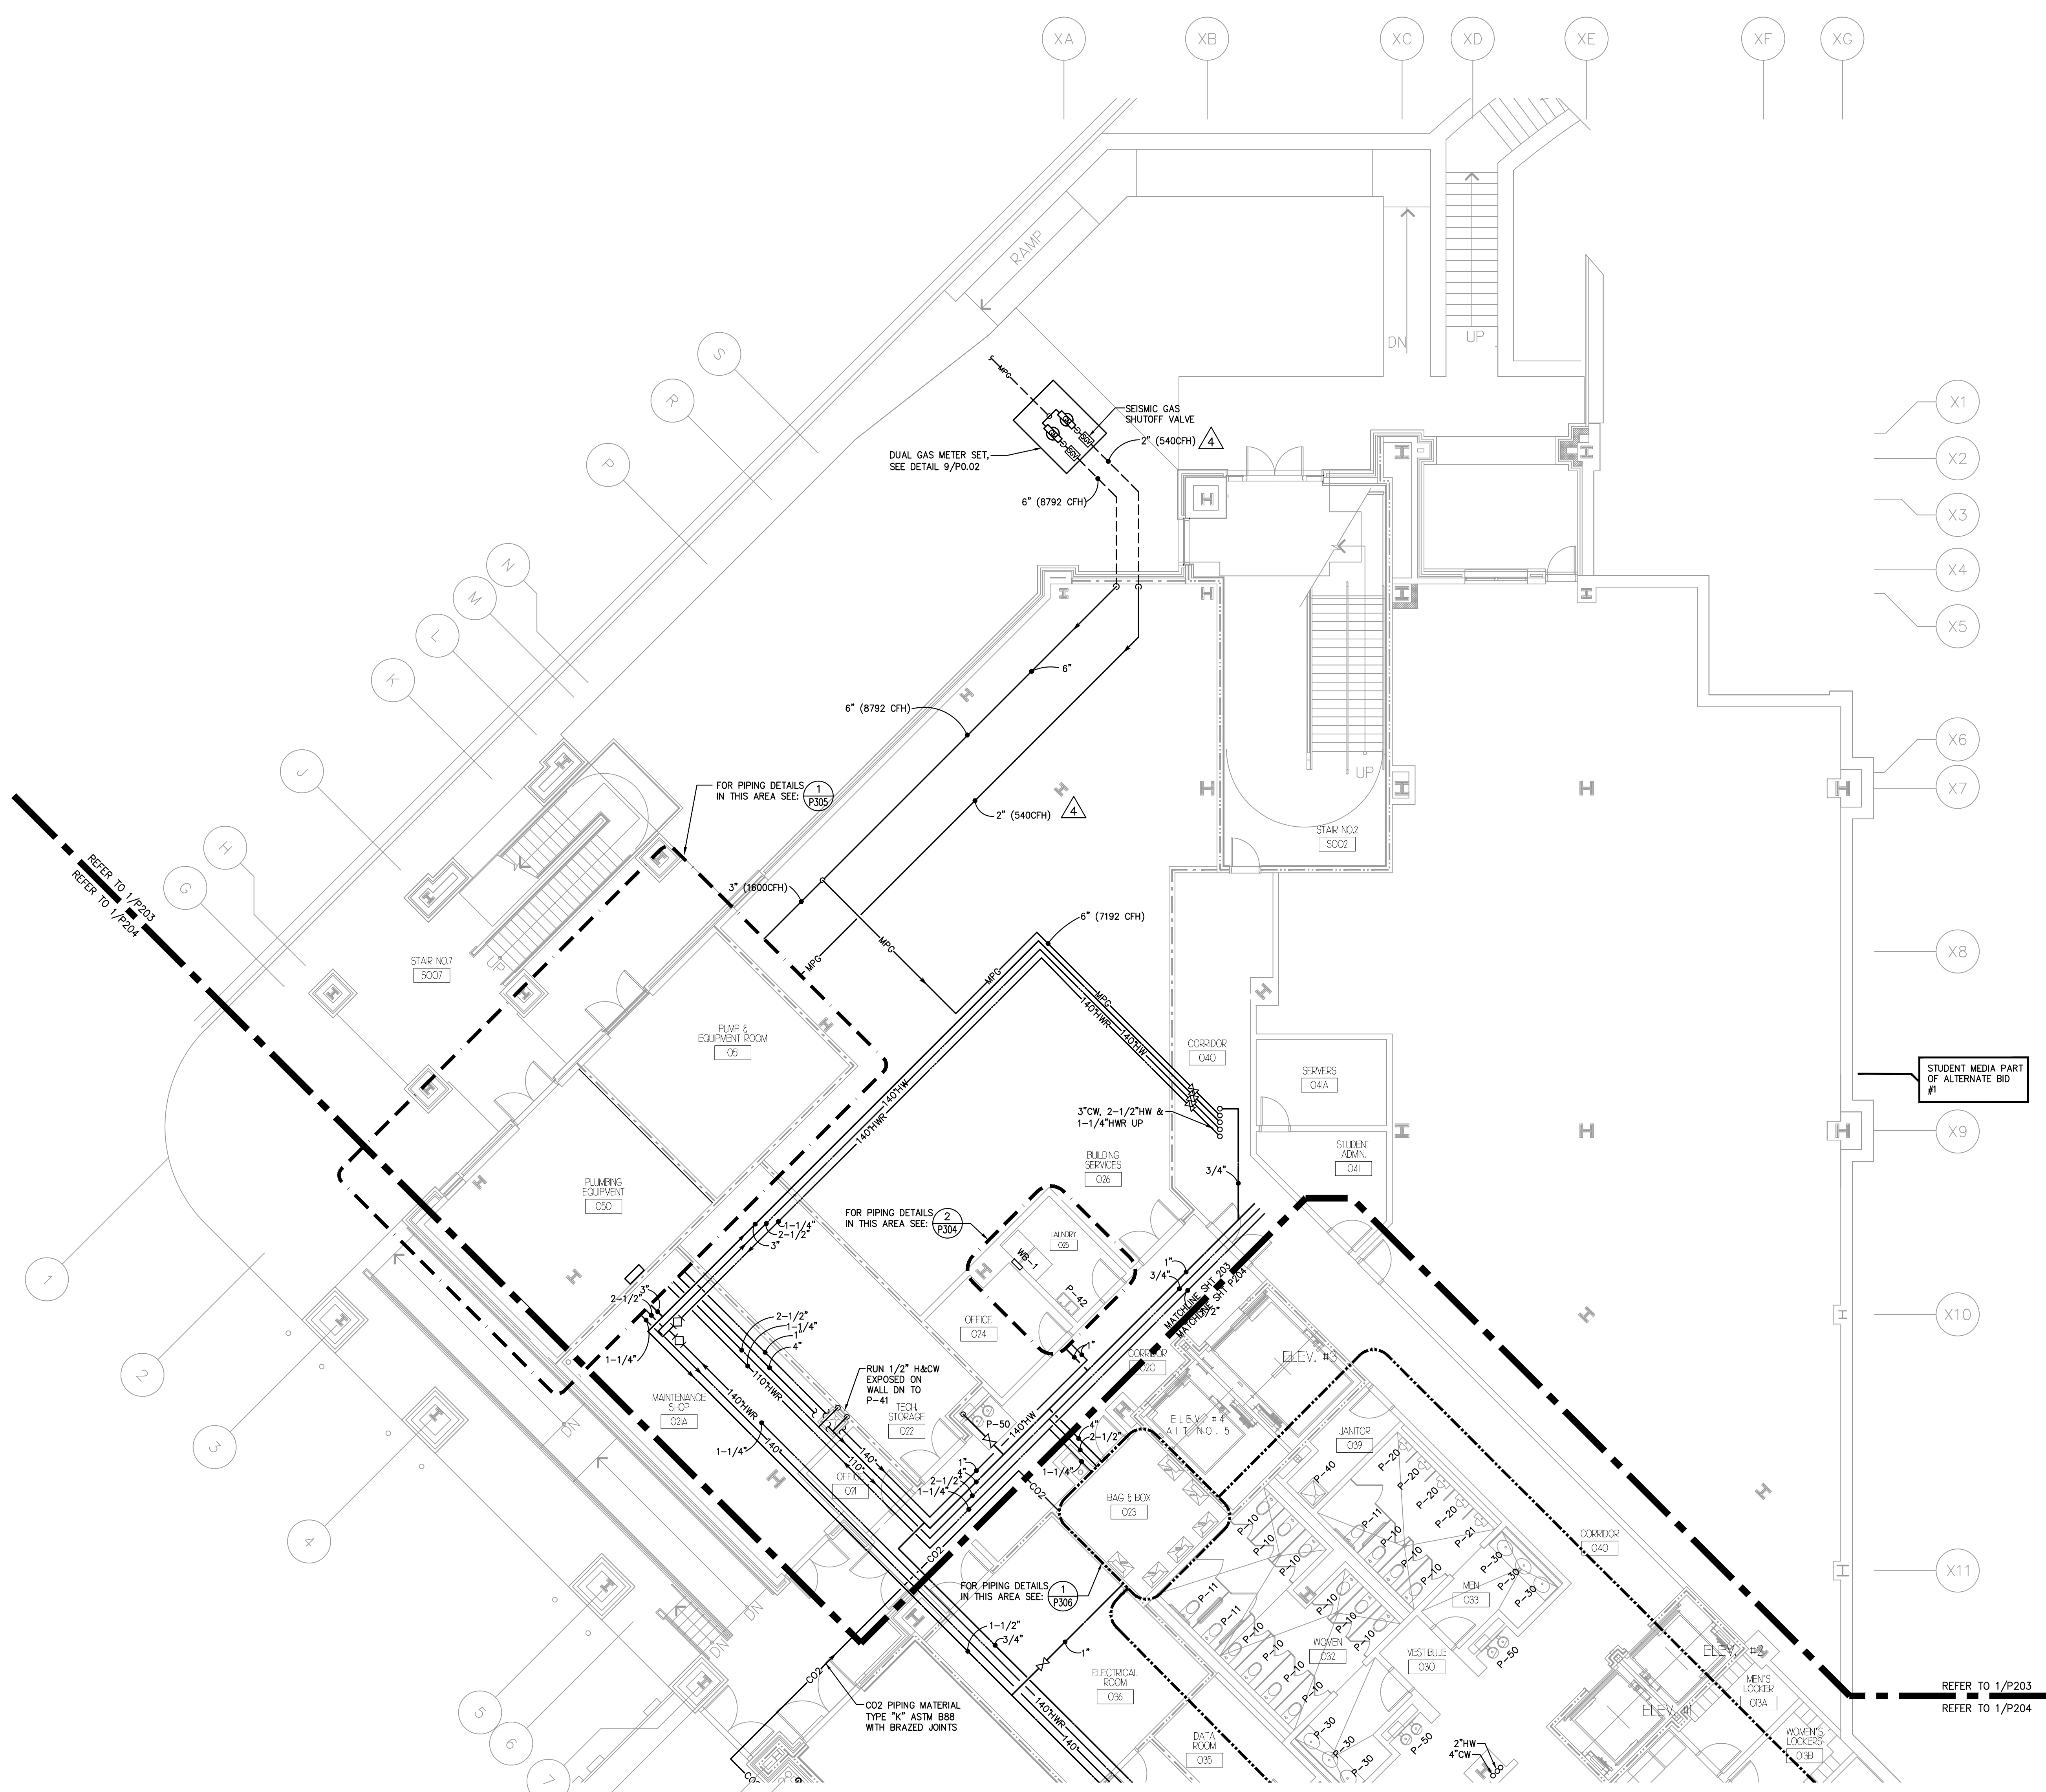

1 LOWER LEVEL PLAN - AREA "A" PRESSURE PIPING - EXISTING
P203 SCALE: 1/8" = 1'-0"